

 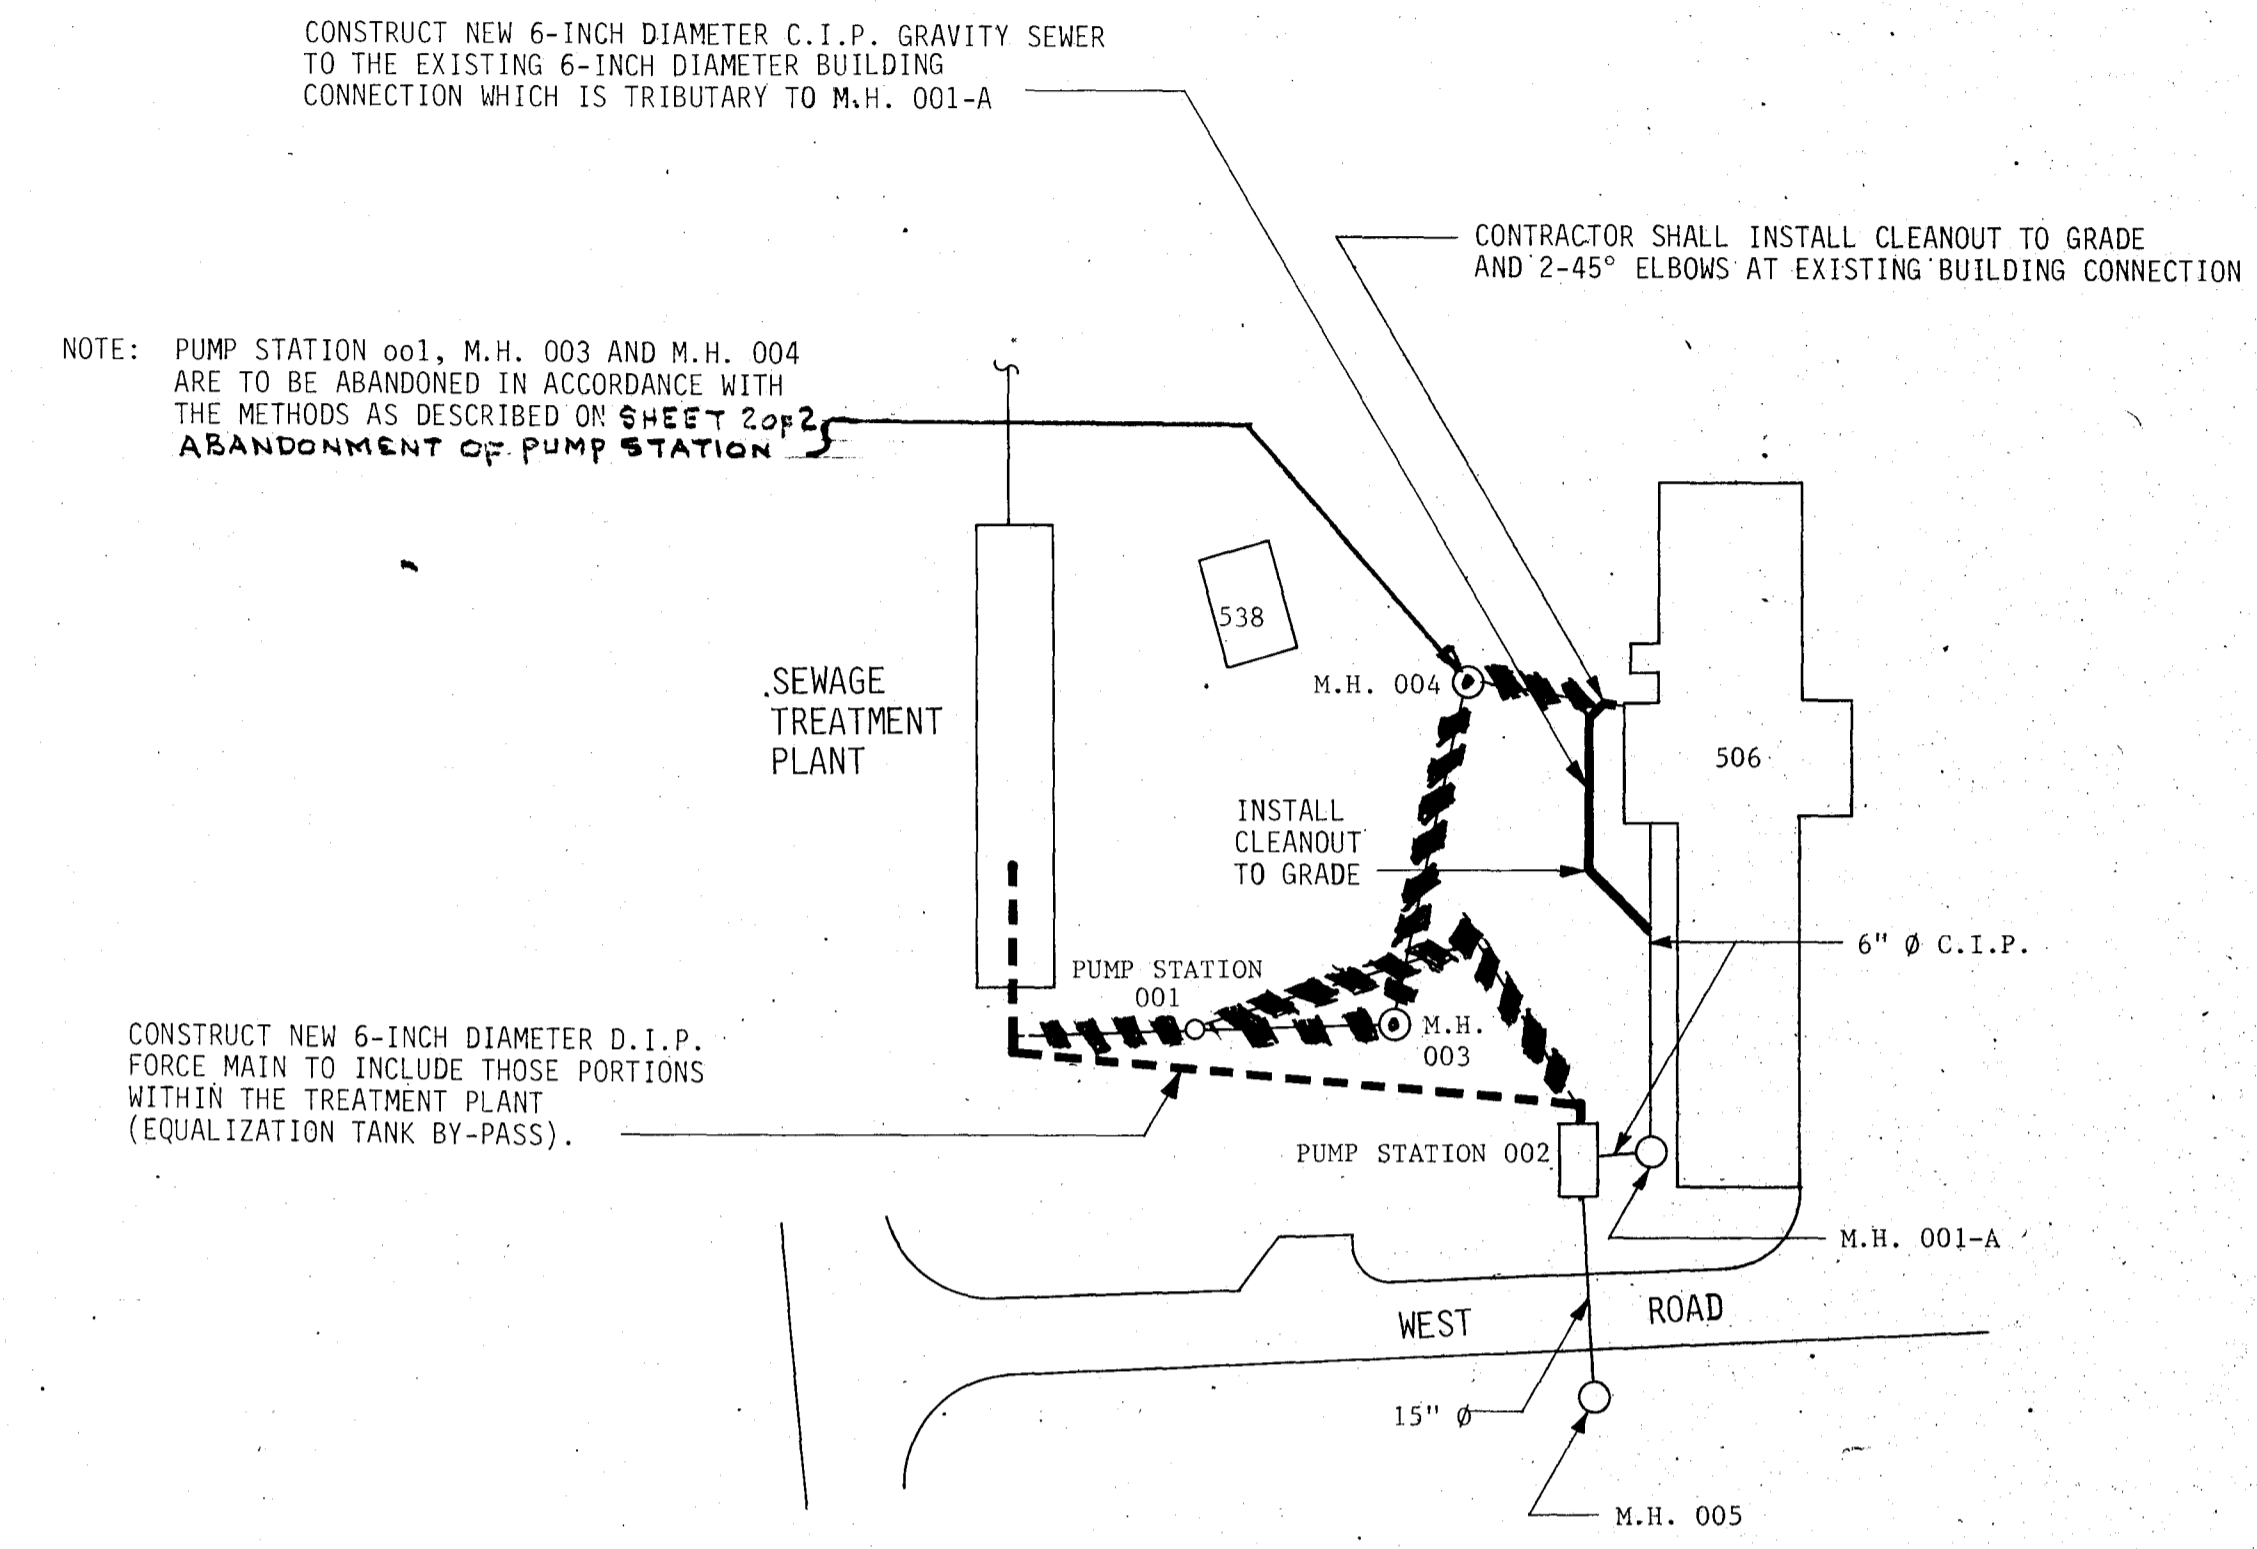


SEE DETAIL THIS SHEET

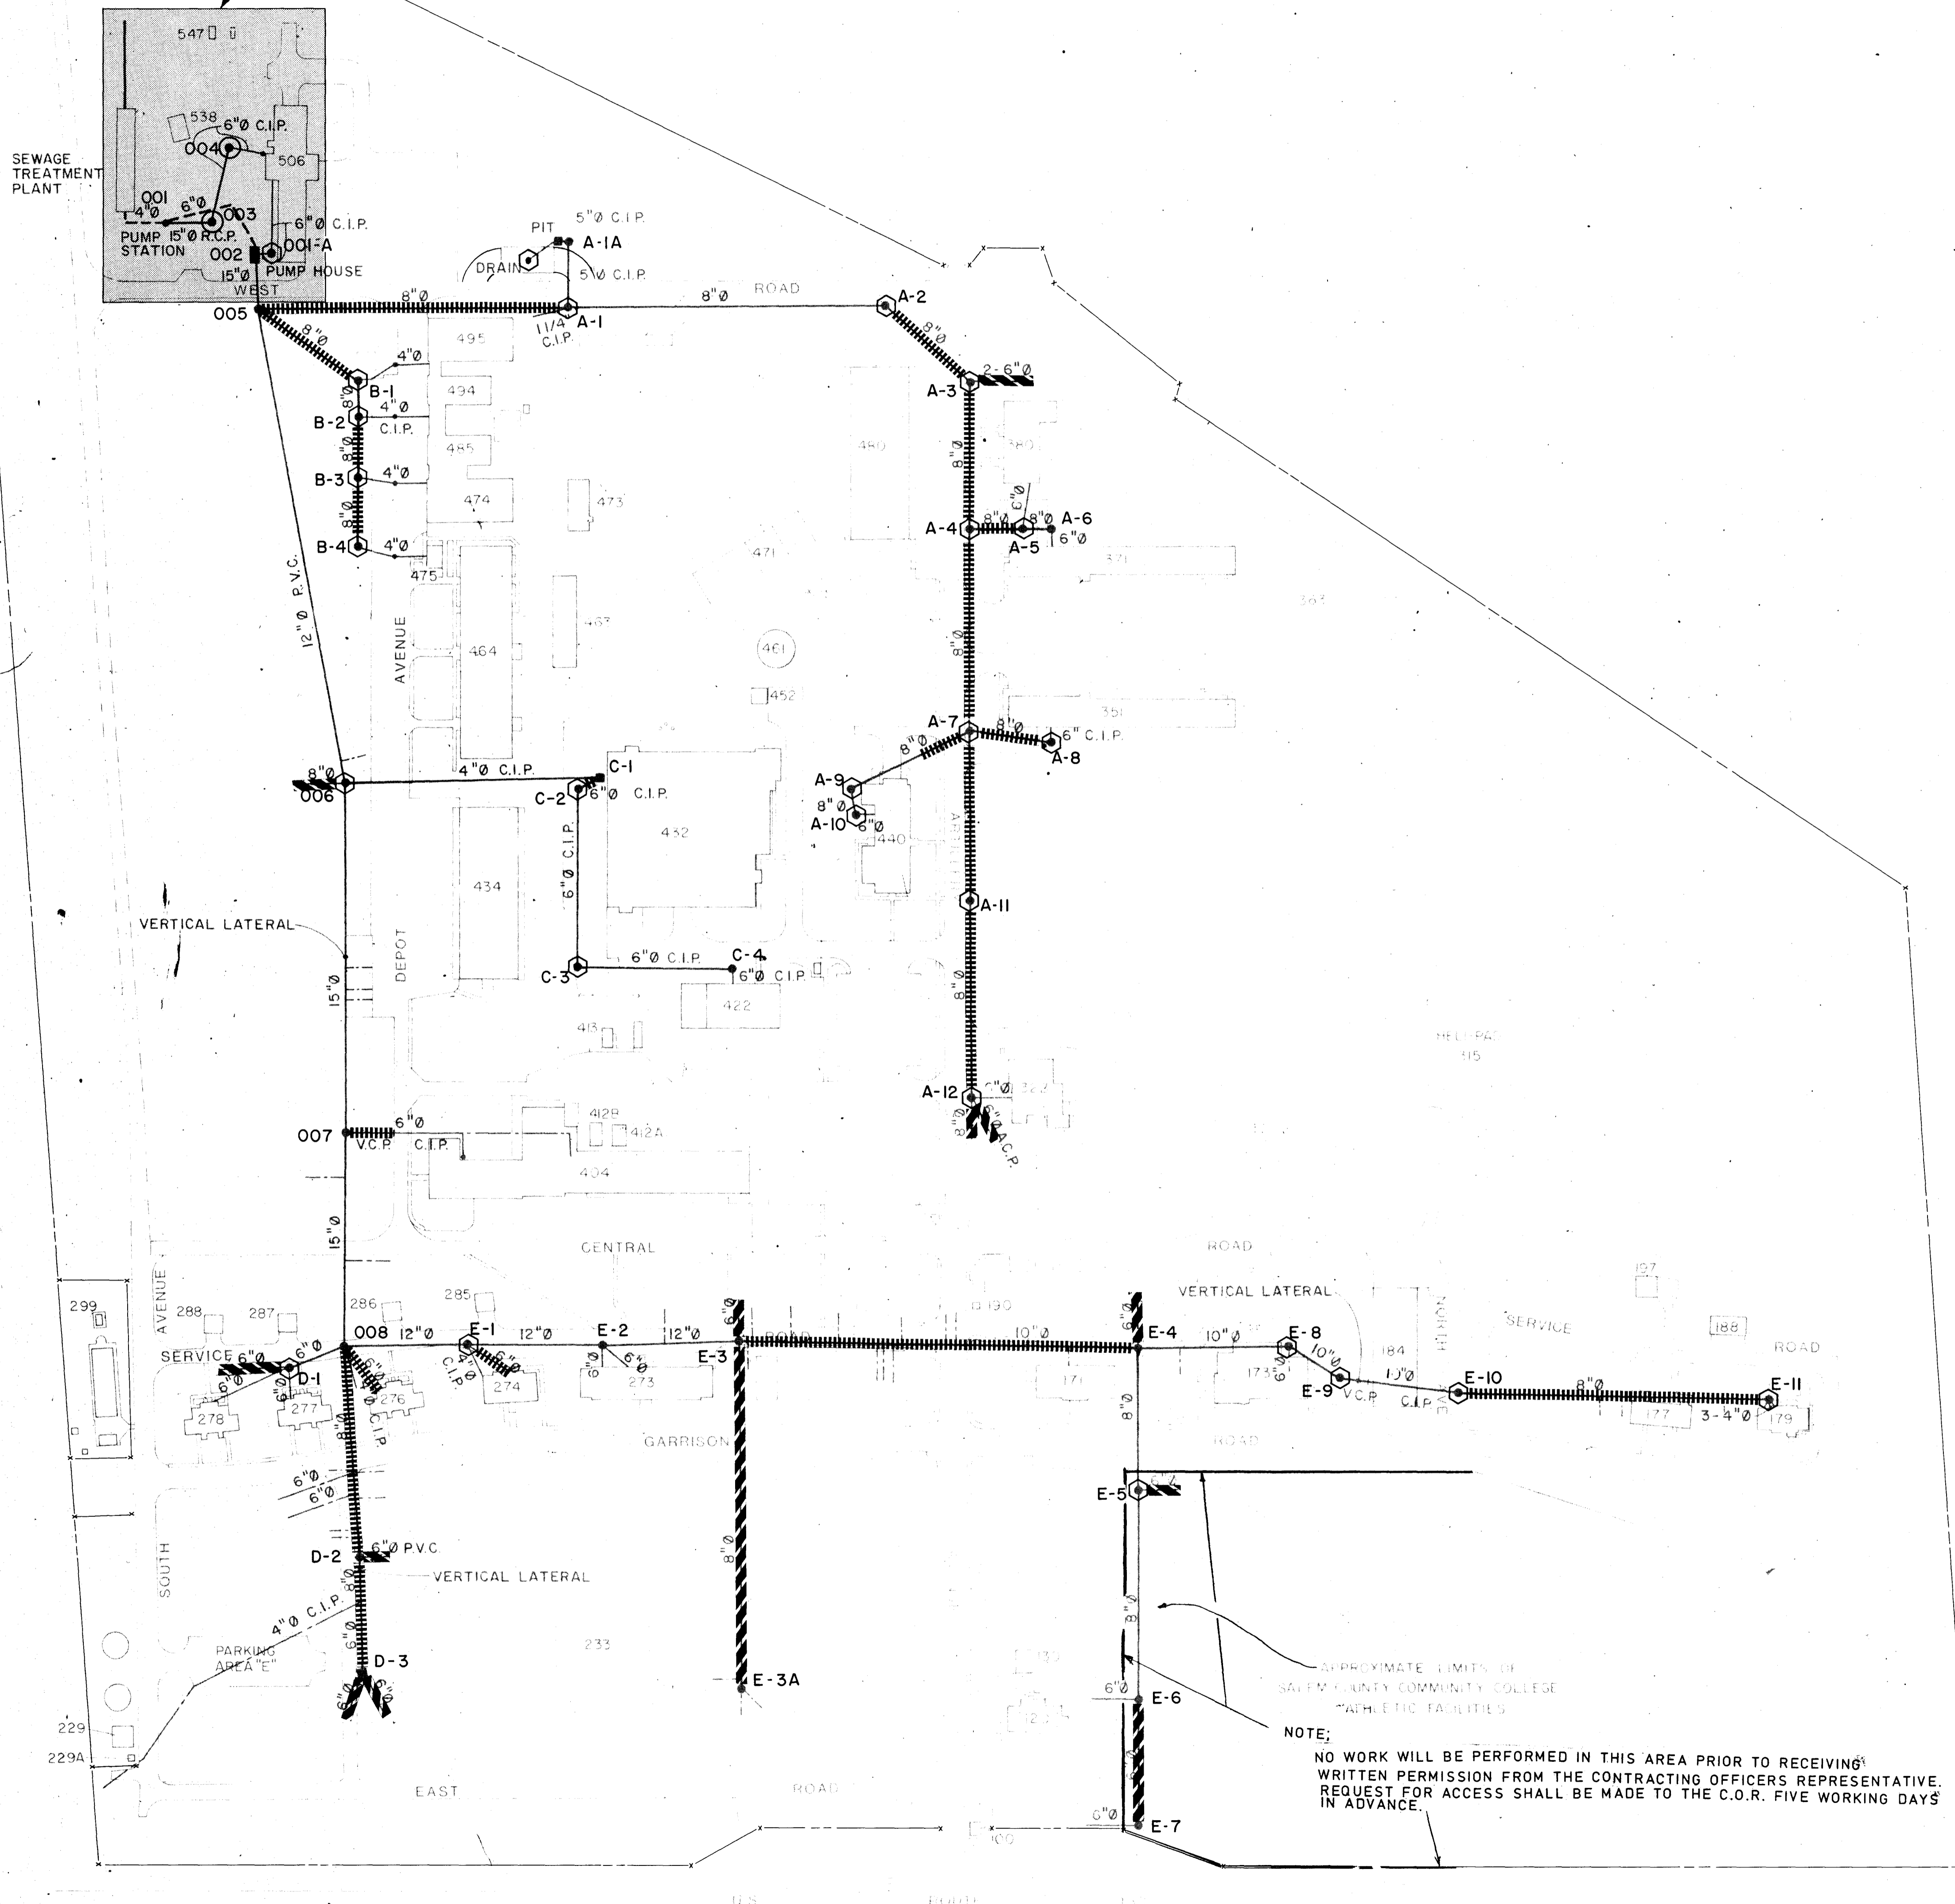

RAW SEWAGE PUMPING STATION MODIFICATIONS

DETAIL



LEGEND

- REHABILITATE REACH
- SEAL/ABANDON REACH
- REHABILITATE MANHOLE
- MANHOLE TO BE ABANDONED
- EXISTING GRAVITY SEWER
- NEW GRAVITY SEWER
- EXISTING FORCE MAIN
- NEW FORCE MAIN

NJ013_07421

NOTE:
APPROXIMATE LIMITS OF
SALVEMOUNT COMMUNITY COLLEGE
ATHLETIC FACILITIES

NOTE:
NO WORK WILL BE PERFORMED IN THIS AREA PRIOR TO RECEIVING
WRITTEN PERMISSION FROM THE CONTRACTING OFFICERS REPRESENTATIVE.
REQUEST FOR ACCESS SHALL BE MADE TO THE C.O.R. FIVE WORKING DAYS
IN ADVANCE.



SYMBOL	DESCRIPTION	DATE	APPROVED
REVISIONS			
Elson T. Kilam Associates, Inc. <small>Environmental and Hydraulic Engineers 27 Stone Street, Newark, New Jersey, 07102</small>			
UNITED STATES ARMY TRAINING CENTER AND FORT DIX DIRECTORATE OF ENGINEERING AND CONSTRUCTION FORT DIX, NEW JERSEY 08841			
DRAWN	E.T.	FACILITY NO.	
DESIGNED	I.P.H.	PEDRICKTOWN	
CHECKED	J.G.C.	ARMY SUPPORT FACILITY	
FP&P DIV		SANITARY SEWER IMPROVEMENT	
B&G DIV		PEDRICKTOWN	
UTL DIV		SITE PLAN AND DETAIL	
USING AGENCY		SCALE: AS NOTED	DRAWING NUMBER
RECOMMENDED		DATE: 6/6/86	84-13-01
APPROVED		PR. NR: GM 13 84	SHEET 1 OF 2