



PLAN

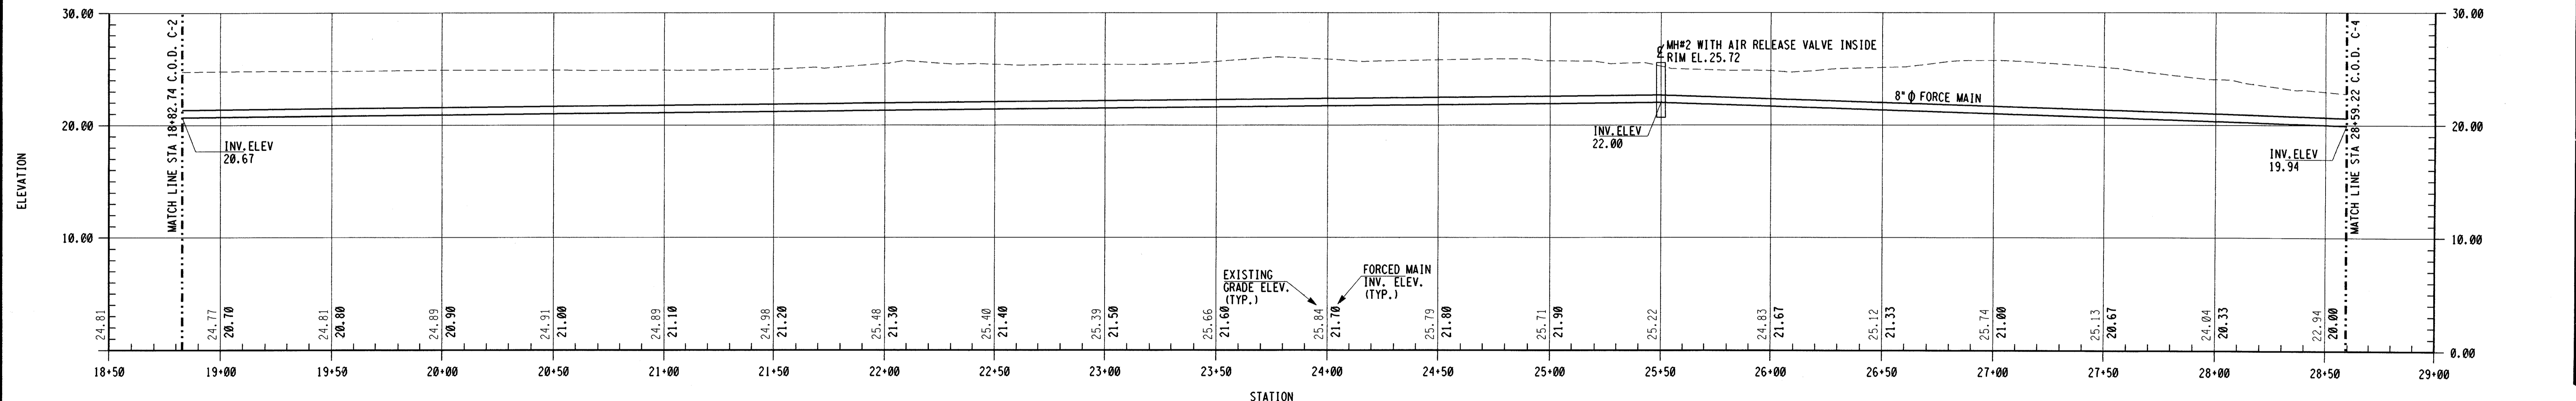

PROFILE

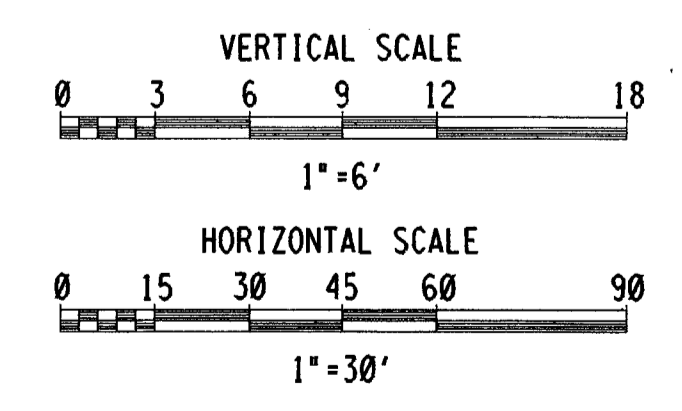

NJ013_0119

SYMBOL	DESCRIPTION	DATE	APPROVED
REVISIONS			
FOSTER WHEELER USA CORPORATION <small>PERRYVILLE CORPORATE PARK, CLINTON, N.J.</small>			
UNITED STATES ARMY GARRISON FORT DIX DIRECTORATE OF PUBLIC WORKS <small>FORT DIX, NEW JERSEY 08640</small>			
DRAWN	JJG	NEW WASTEWATER LIFT STATION AND FORCED MAIN SIEVERS-SANDBERG US ARMY RESERVE CENTER PEDRICKTOWN, NEW JERSEY	
DESIGNED	WRL		
CHECKED	JCM		
FP&P DIV			
ENV DIV			
O & M DIV	DOTM	SITE PLAN	
RECOMMENDED:	USING AGENCY	SCALE: 1" = 30'	DRAWING NUMBER
	CHIEF ENGINEERING PLANS & SERVICES	DATE: OCT. 25, 1996	C-3
APPROVED:	REGIONAL DIRECTORATE OF PUBLIC WORKS	PR. NR: GM-00036-5P	SHEET 12 OF 18

13-05-37389