



PLAN

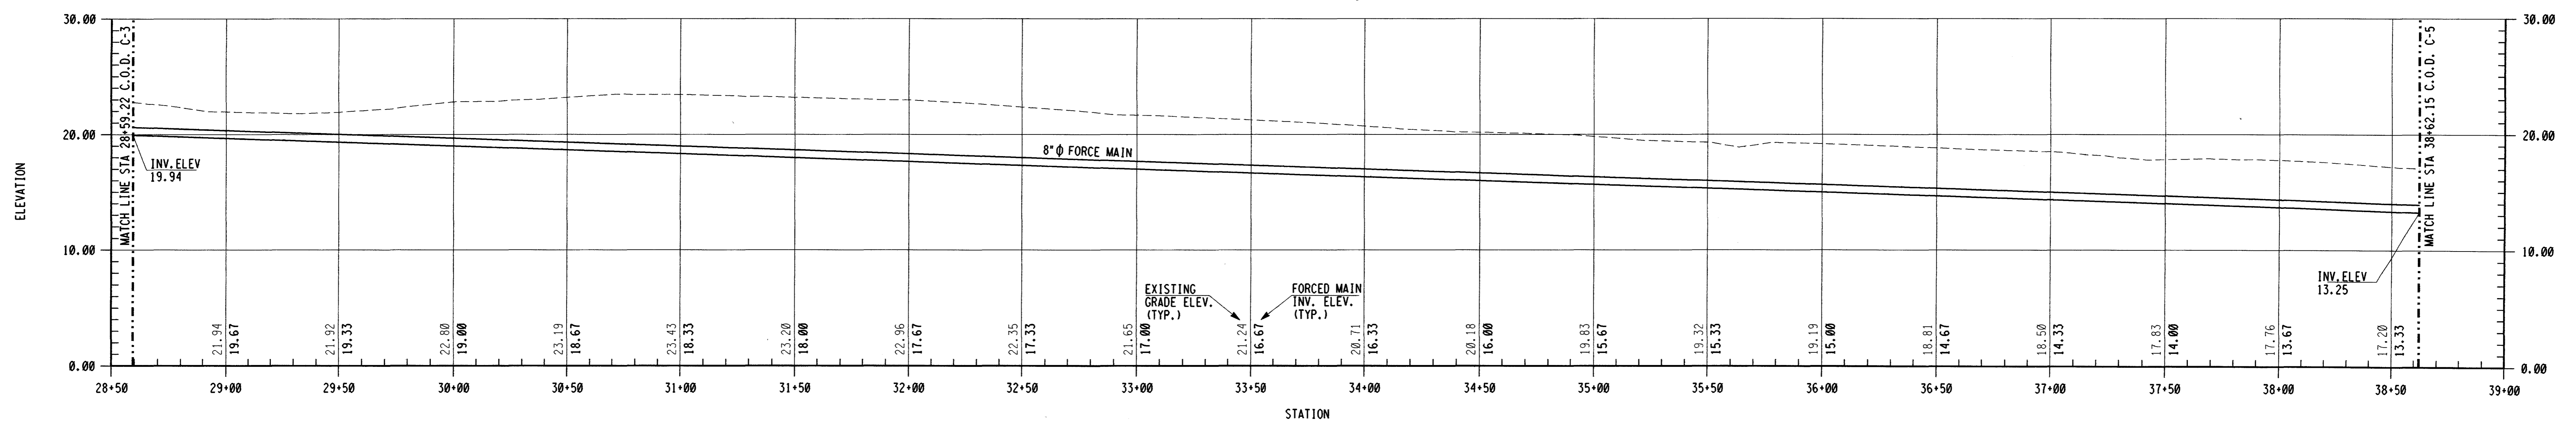

PROFILE

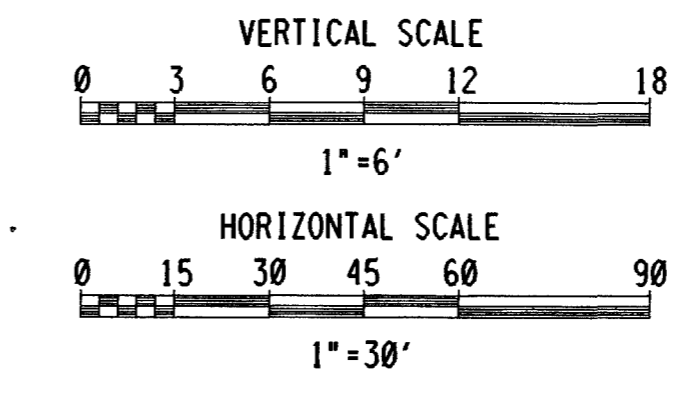

NJ013_0120

SYMBOL	DESCRIPTION	DATE	APPROVED
REVISIONS			
FOSTER WHEELER USA CORPORATION <small>PERRYVILLE CORPORATE PARK, CLINTON, N.J.</small>		UNITED STATES ARMY GARRISON FORT DIX DIRECTORATE OF PUBLIC WORKS FORT DIX, NEW JERSEY 08640	
DRAWN	JJG	NEW WASTEWATER LIFT STATION AND FORCED MAIN SIEVERS-SANDBERG US ARMY RESERVE CENTER PEDRICKTOWN, NEW JERSEY	
DESIGNED	WRL		
CHECKED	JCM		
FP&P DIV			
ENV DIV	USING AGENCY	SITE PLAN	
O & M DIV	DOTM		
RECOMMENDED:	CHIEF ENGINEERING PLANS & SERVICES	SCALE: 1" = 30'	DRAWING NUMBER C-4
APPROVED:	REGIONAL DIRECTORATE OF PUBLIC WORKS	DATE: OCT. 25, 1996	
		PR. NR: GM-00036-5P	SHEET 13 OF 18

13-05-37389