


- LEGEND**
- INDICATES ABANDONED/REMOVED UNDERGROUND PIPE OR STRUCTURE FROM RECORD DRAWINGS.
  - INDICATES ACTIVE/IN USE UNDERGROUND PIPE OR STRUCTURE FROM RECORD DRAWINGS.
  - INDICATES ITEM/SYSTEM/STRUCTURE TO BE ABANDONED/REMOVED PER SPECIFICATIONS.
  - INDICATES DOUBLE ARM AREA LIGHT STANCHION.
  - INDICATES NEW LINE FOR RE-DIRECTED SEWAGE FLOW.
  - EXISTING CONTOUR ELEVATION (APPROXIMATE).
  - PROPOSED CONTOUR ELEVATION.
  - SILT FENCE.
  - LIMITS OF DISTURBED AREA.
  - LINE SERVICE: S = SANITARY  
ST = STORM  
W = WATER

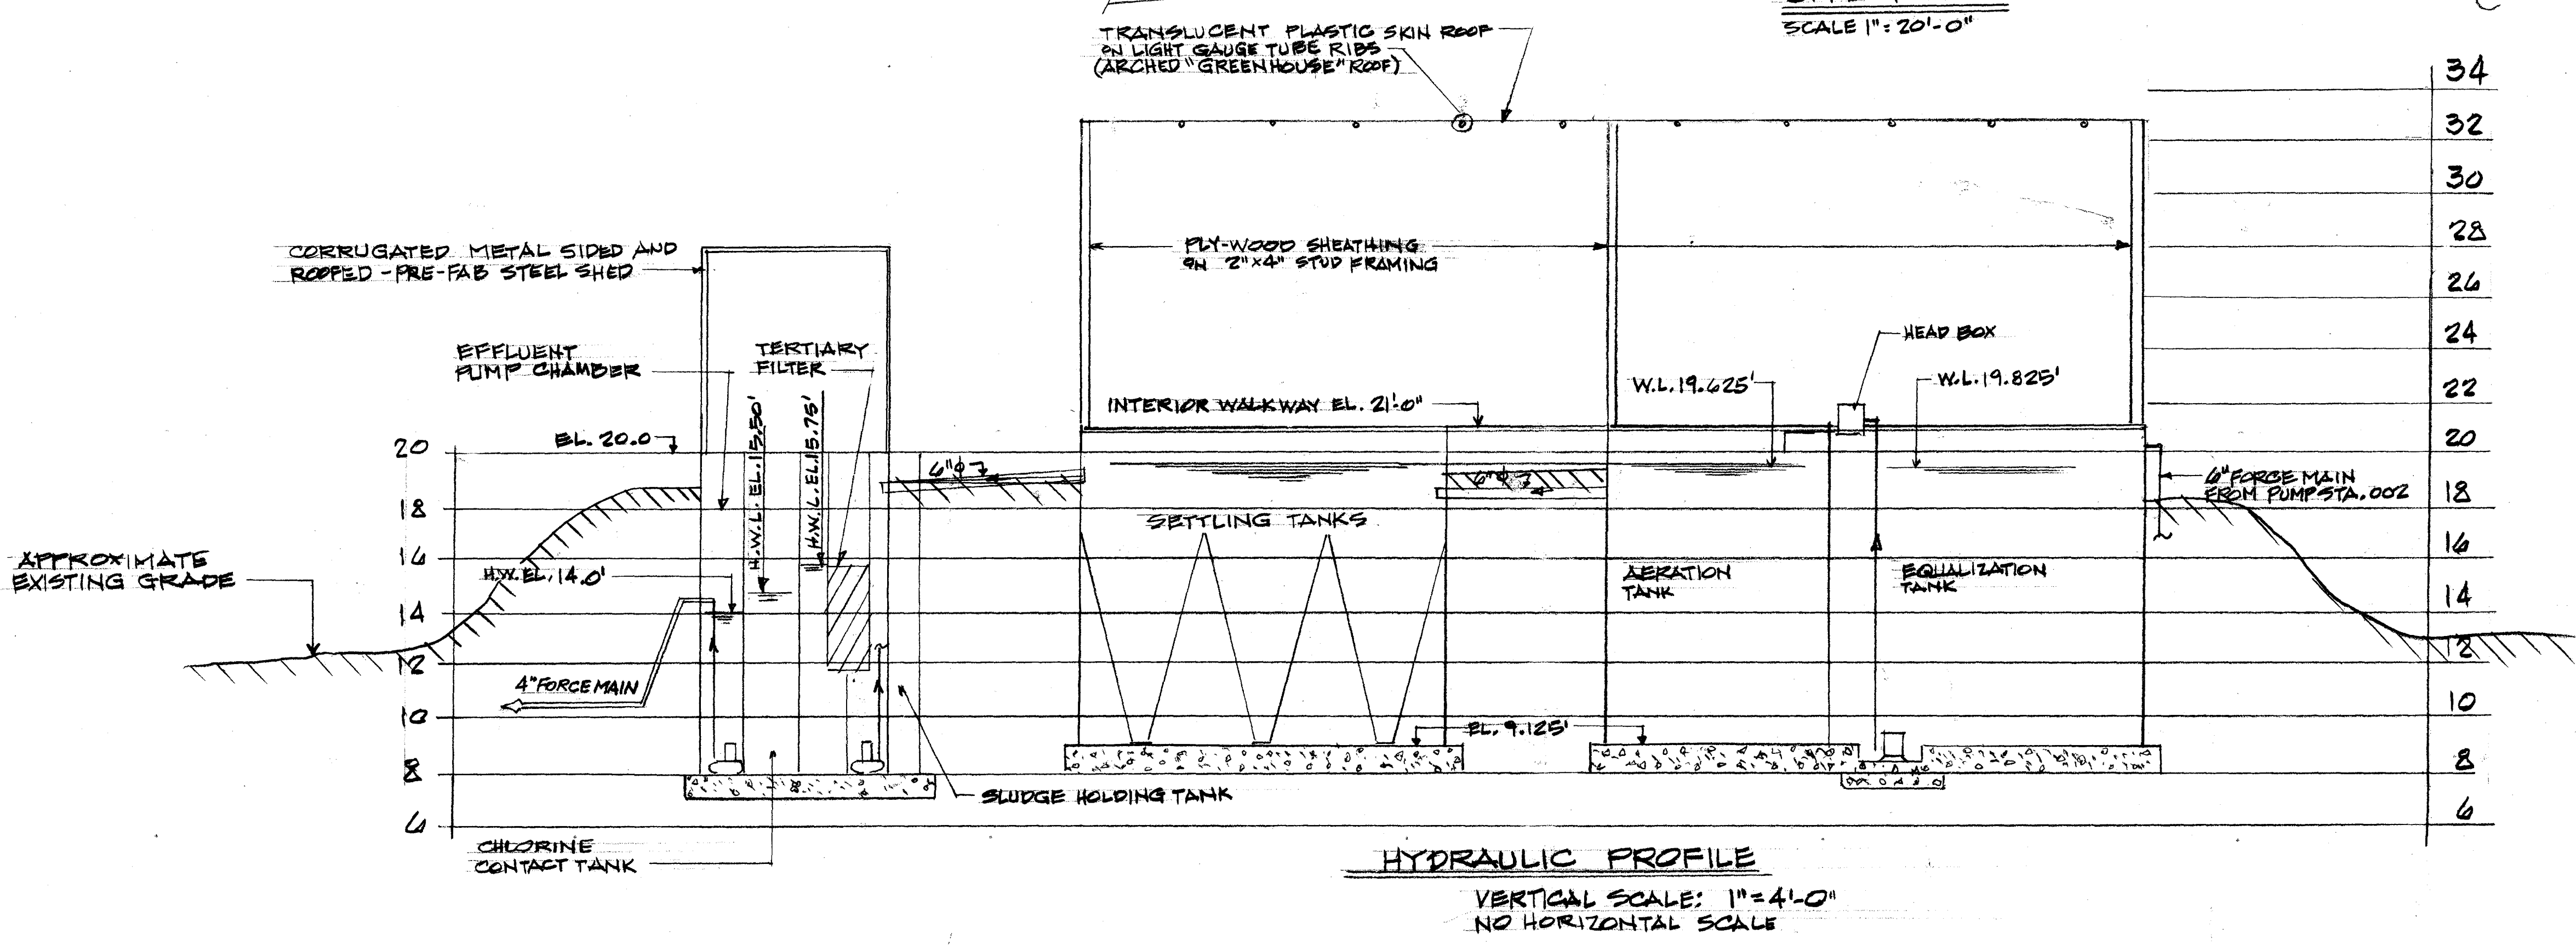

NJ013-0111

SYMBOL	DESCRIPTION	DATE	APPROVED	
REVISIONS				
 FOSTER WHEELER USA CORPORATION PERRYVILLE CORPORATE PARK, CLINTON, N.J.		UNITED STATES ARMY - FORT DIX DIRECTORATE OF PUBLIC WORKS FORT DIX, NEW JERSEY 08640		
DRAWN	N. A.	NEW WASTEWATER LIFT STATION AND FORCE MAIN SEIVERS-SANDBERG U.S. ARMY RESERVE CENTER PEDRICKTOWN, NEW JERSEY DEMOLITION SITE PLAN/HYDRAULIC PROFILE		
DESIGNED	N. A.			
CHECKED	P. F. E.			
FP&P DIV				
B&G DIV				
UTIL. DIV		RECOMMENDED:	SCALE: AS NOTED	DRAWING NUMBER
USING AGENCY		Chief Engineering, plans & SERVICES	DATE: OCT. 25, '96	PLATED-1
APPROVED:		Director of Engineering & Housing	PR. NR: GM-00036-5P	SHEET 4 OF 18

13-05-37389

37389