


PLAN

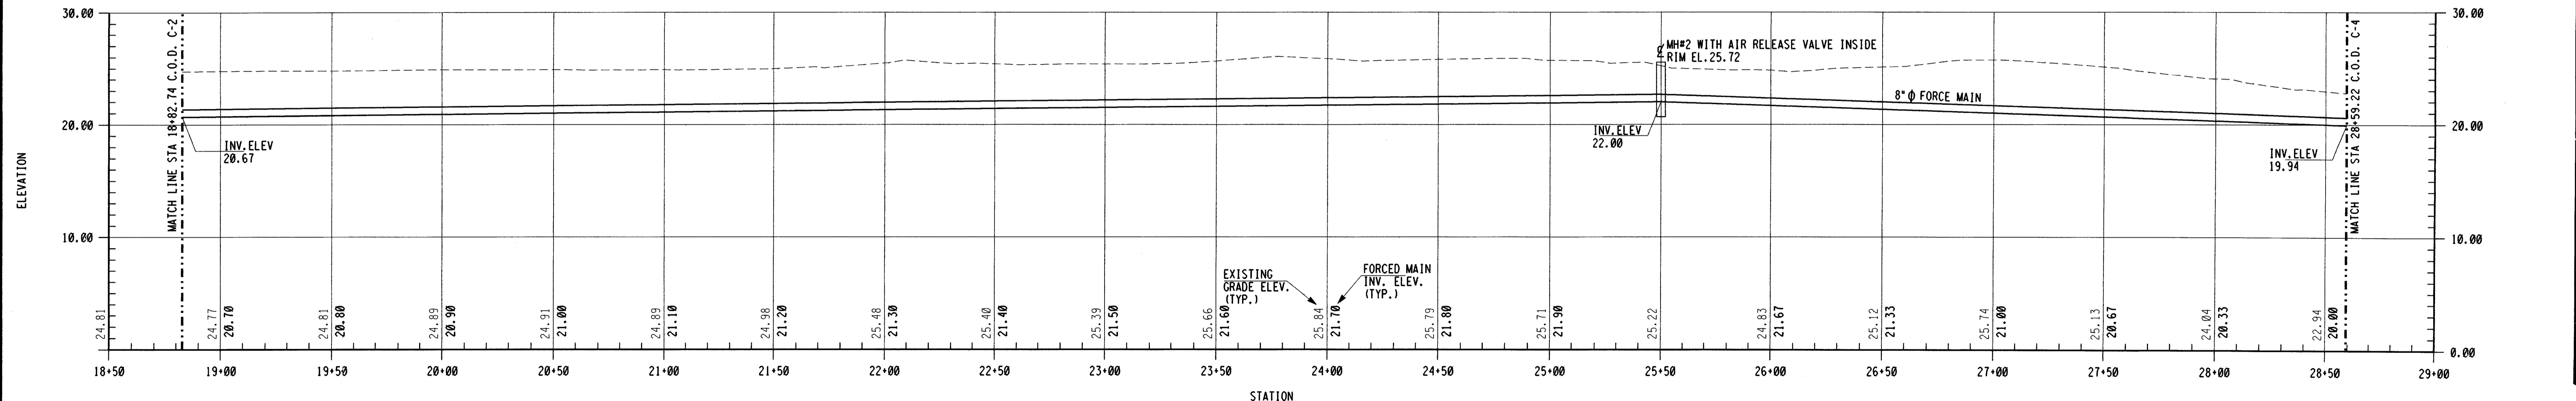

PROFILE

NJ013_0119

SYMBOL	DESCRIPTION	DATE	APPROVED
FOSTER WHEELER USA CORPORATION <small>PERRYVILLE CORPORATE PARK, CLINTON, N.J.</small>			
UNITED STATES ARMY GARRISON FORT DIX DIRECTORATE OF PUBLIC WORKS <small>FORT DIX, NEW JERSEY 08640</small>			
DRAWN: JJC DESIGNED: WRL CHECKED: JCM FP&P DIV ENV DIV O & M DIV RECOMMENDED: APPROVED:	USING AGENCY: DOIM CHIEF ENGINEERING PLANS & SERVICES REGIONAL DIRECTORATE OF PUBLIC WORKS	NEW WASTEWATER LIFT STATION AND FORCED MAIN SIEVERS-SANDBERG US ARMY RESERVE CENTER PEDRICKTOWN, NEW JERSEY SITE PLAN	
SCALE: 1"=30' DATE: OCT. 25, 1996 PR.NR: GM-00036-5P		DRAWING NUMBER: C-3 SHEET 12 OF 18	

13-05-37389